

THIS DOCUMENT IS A PROPERTY OF MAPNA AND IT MUST NOT BE COPIED,
NOR TRANSFERRED TO A THIRD PARTY WITHOUT PRIOR AUTHORIZATION

1

2

3

A

B

C



D

E



F

SORKHANKALATEH

63/20 KV SUBSTATION

GENERAL LAYOUT & SECTIONS

REFERENCE DOCUMENT & DWG

LEGENDS

NOTES

KEY PLAN

D	ISSUE FOR APPROVE	GHAFOURAN	GHAFOURAN	MANDORI	MANDORI	DANESHPOU	04.02.21
C	ISSUE FOR APPROVE	GHAFOURAN	GHAFOURAN	MANDORI	MANDORI	DANESHPOU	04.01.23
B	ACC TO LET NO.1403/179502/52320	EMARLOO	MANDORI	MANDORI	MANDORI	DANESHPOU	03.12.06
A	ACC TO LET NO.1403/179502/43747	EMARLOO	MANDORI	MANDORI	MANDORI	DANESHPOU	03.10.03
O	FIRST ISSUE	EMARLOO	MANDORI	MANDORI	MANDORI	DANESHPOU	03.07.14
Rev.	DESCRIPTION	DRAWN	DESIGNED	CHKD.	HEAD	APPR.	DATE



Magna Power Plants Construction &
Development Co(MD-I)



MOHAM
SHARGH
CO.



GHODS NIROO
CONSULTING ENGINEERS

 
PROJECT: SORKHANKALATEH 63/20KV AIS S/S

TITLE: GENERAL LAYOUT & SECTIONS


OWNER'S DWG. NO. : MD1-BQ-06-SS-E-01-NYO-706 REV. NO. : D

SCALE : AS SHOWN FORMAT : A3 FILE NO. : SHEET: 0 OF: 8

CONTRACT NO. : MD1-BQ-06-SS-E-01-NYO-706 DESIGN TYPE : BASIC DESIGN ☐ DETAIL DESIGN ☐



MAZANDARAN
REGIONAL ELECTRIC
COMPANY
(M.R.E.C)

 


SUB-CONTRACTOR'S LOGO

GHAFOURAN	GHAFOURAN	MANDORI	MANDORI	DANESHPOU	04.02.21
DRAWN	DESIGNED	CHKD.	HEAD	APPR.	DATE





MAPNA'S DWG. NO. : MD1-BQ-06-SS-E-01-NYO-706 REV. NO. : D SUB CONTRACTOR DWG. NO.: D

XXXX IN-HOUSE REVISION							
D	ISSUE FOR APPROVE	GHAFOURAN	GHAFOURAN	MANDORI	MANDORI	DANESHPOU	1404.02.21
C	ISSUE FOR APPROVE	GHAFOURAN	GHAFOURAN	MANDORI	MANDORI	DANESHPOU	1404.01.23
B	ACC TO LET NO.1403/179502/52320	EMARLOO	MANDORI	MANDORI	MANDORI	DANESHPOU	1403.12.06
A	ACC TO LET NO.1403/179502/43747	EMARLOO	MANDORI	MANDORI	MANDORI	DANESHPOU	1403.10.03
O	FIRST ISSUE	EMARLOO	MANDORI	MANDORI	MANDORI	DANESHPOU	1403.07.14
Rev.	DESCRIPTION	DRAWN	DESIGNED	CHKD.	HEAD	APPR.	DATE




THIS DOCUMENT IS A PROPERTY OF MAPNA AND IT MUST NOT BE COPIED,
NOR TRANSFERRED TO A THIRD PARTY WITHOUT PRIOR AUTHORIZATION

Page	Description	Revision				
		<i>0</i>	<i>A</i>	<i>B</i>	<i>C</i>	<i>D</i>
00	COVER SHEET	X	X	X	X	X
01	INDEX	X	X	X	X	X
02	GENERAL LAYOUT	X	X	X	X	X
03	SECTION A-A	X	X	X	X	X
04	SECTION B-B		X	X	X	X
05	SECTION C-C	X	X	X	X	X
06	SECTION D-D&E-E	X	X	X	X	X
07	SECTION F-F	X	X	X	X	X
08	SECTION G-G	X	X	X	X	X

<div> MAZANDARAN REGIONAL ELECTRIC COMPANY (M.R.E.C)</div>	SUB-CONTRACTOR'S LOGO	E						DWG./Doc. No. MD1-BQ-06-SS-E-01-NYO-706	SCALE :	<div> Mapna Power Plants Construction & Development Co(MD-1)</div>	<div> MOHAM SHARGH CO.</div>	<div> GHODS NIROO CONSULTING ENGINEERS</div>			
		D	ISSUE FOR APPROVE	GHAFOURIAN	GHAFOURIAN	M.NOORI	DANESHPOU						04.02.21		
		C	ACC TO LET NO.1403/179502/52320	GHAFOURIAN	GHAFOURIAN	M.NOORI	DANESHPOU						04.01.23		
	SUB CONTRACTOR DWG. NO.:	B	ACC TO LET NO.1403/179502/52320	EMARLOO	M.NOORI	M.NOORI	DANESHPOU						03.12.06	DRAWING TITLE: INDEX	REV. NO. : D SHEET: 1 OF: 8
		A	ACC TO LET NO.1403/179502/43747	EMARLOO	M.NOORI	M.NOORI	DANESHPOU						03.10.03		
MAPNA'S DWG, No. : MD1-BQ-06-SS-E-01-NYO-706	NIYAM'S LOGO	O	FIRST ISSUE	EMARLOO	M.NOORI	M.NOORI	DANESHPOU	03.07.14	DESIGN STAGE :	FILE No.	FORMAT : A3	PROJECT : SORKHANKALATEH 63/20KV AIS S/S			
		REV.	DESCRIPTION	DWN	DESN	CHKD	APPR	DATE							

THIS DOCUMENT IS A PROPERTY OF MAPNA AND IT MUST NOT BE COPIED, NOR TRANSFERRED TO A THIRD PARTY WITHOUT PRIOR AUTHORIZATION

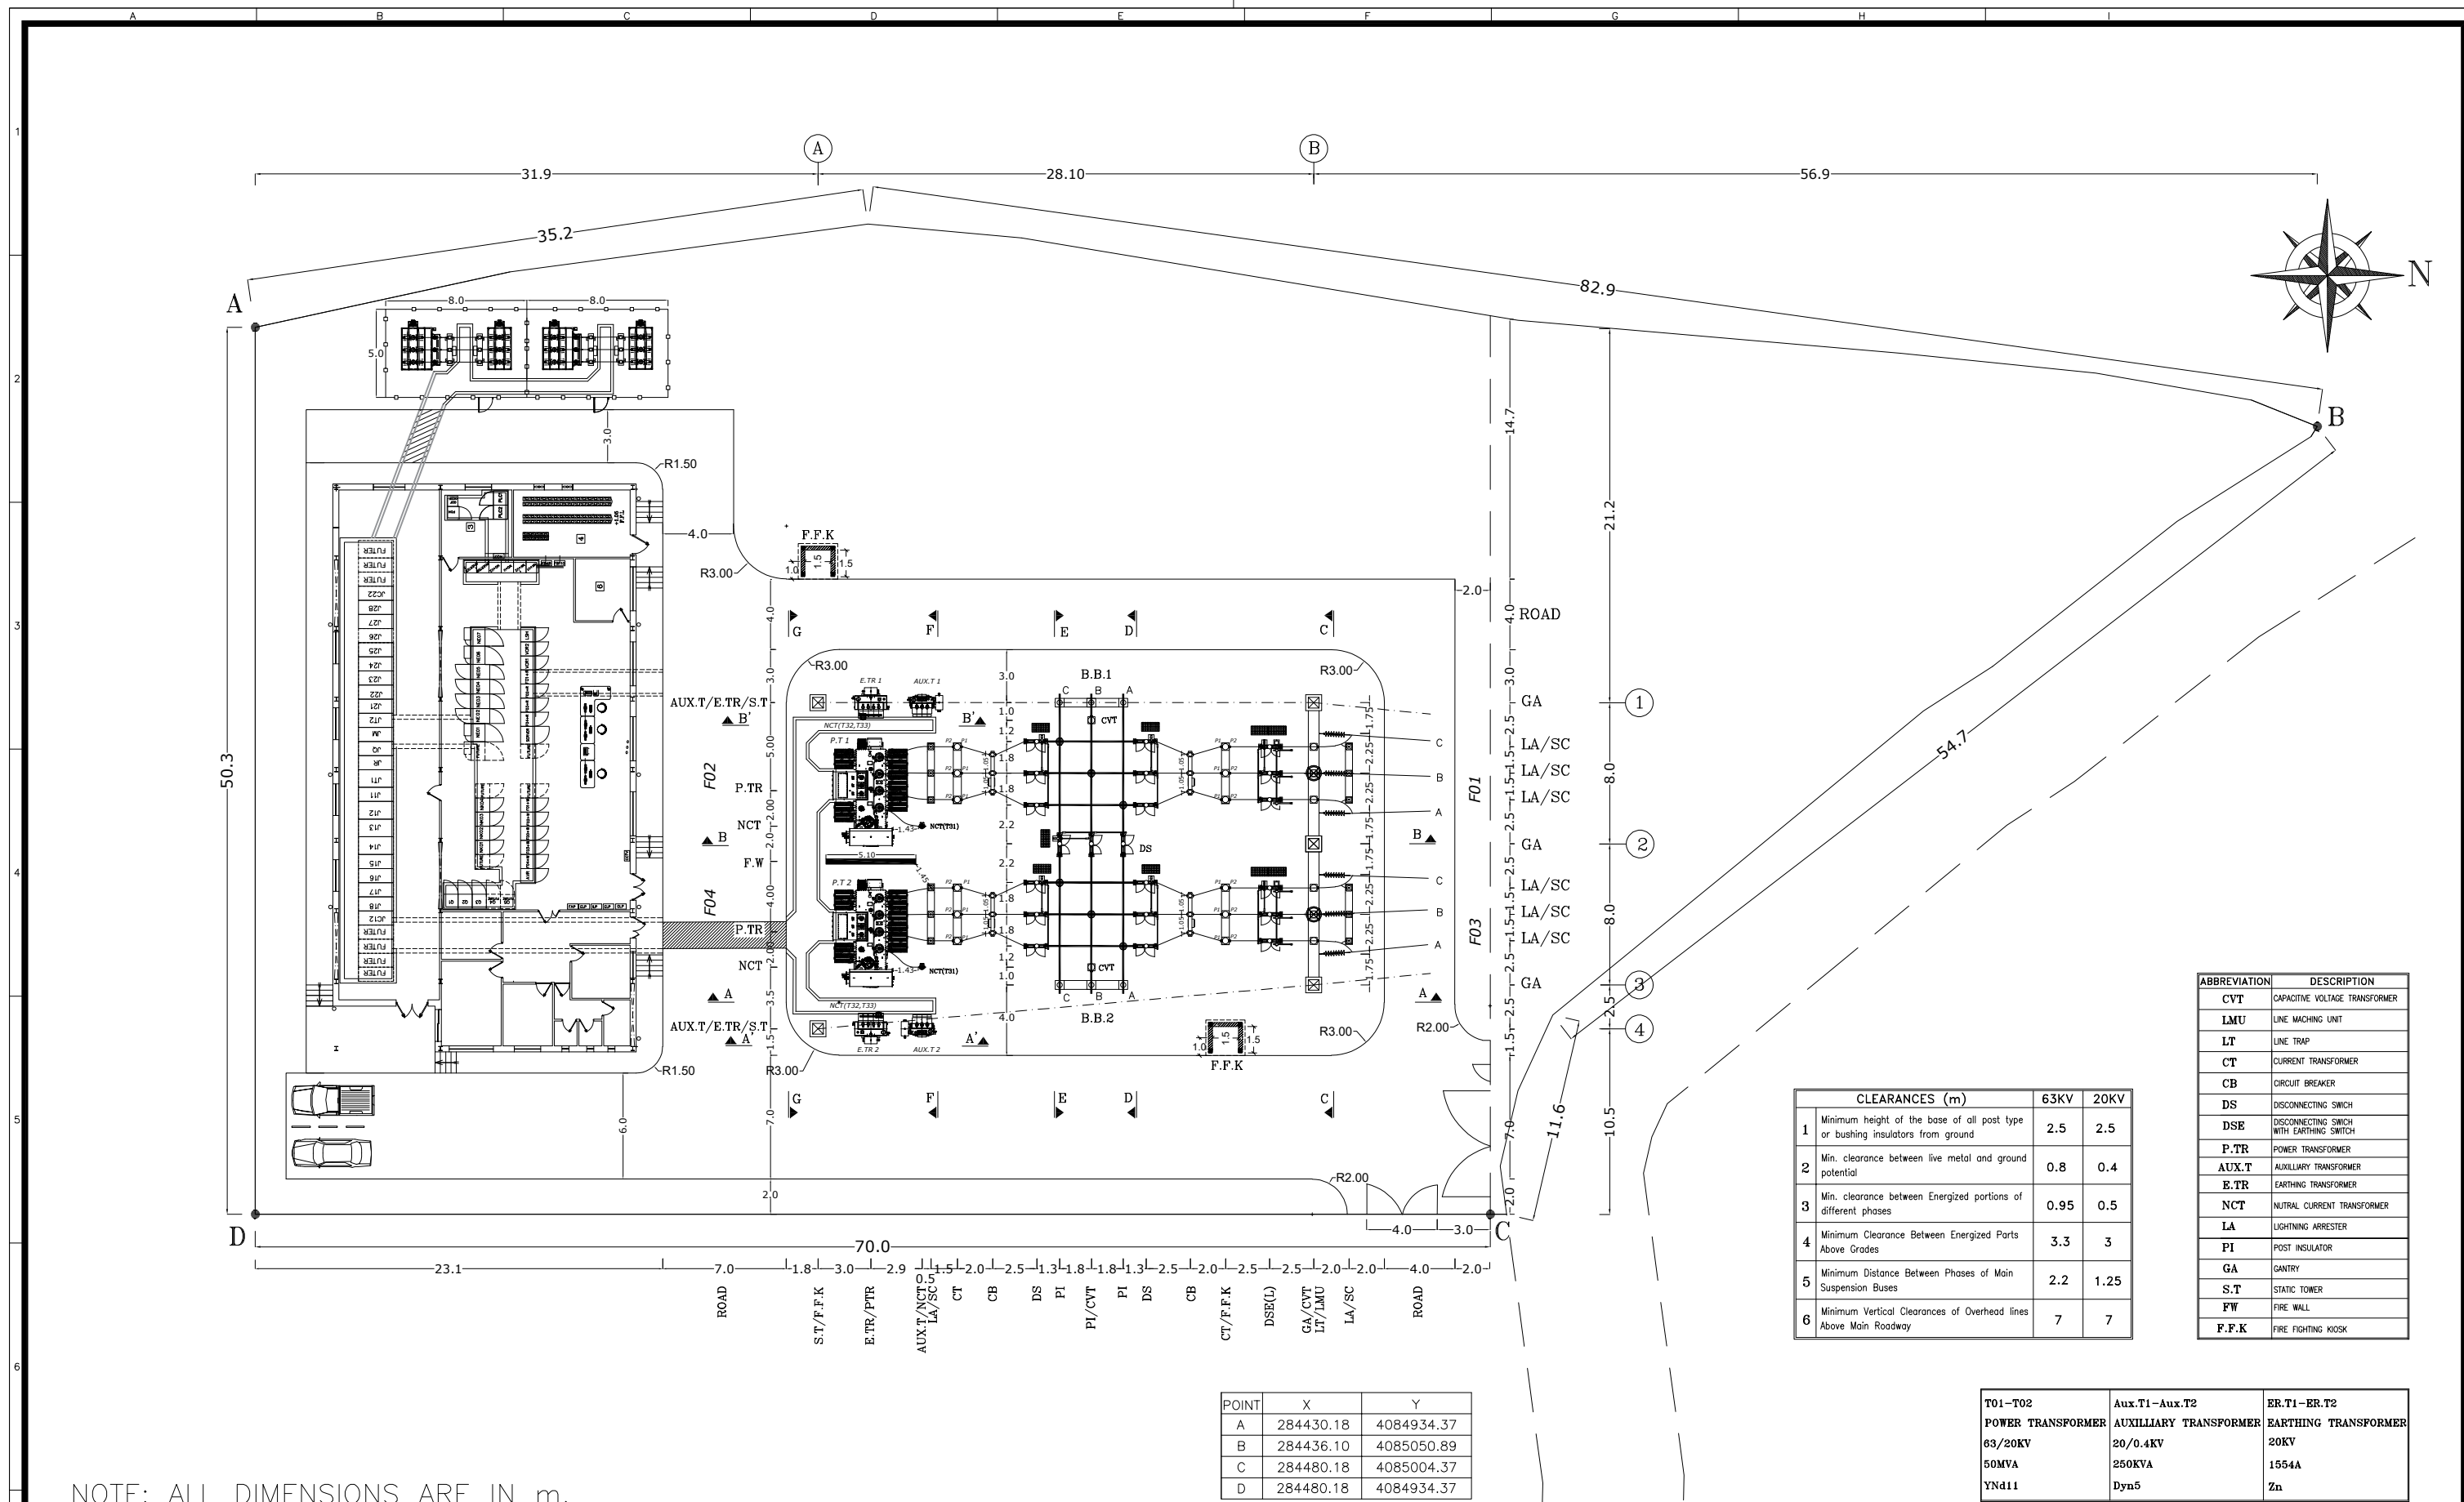

NOTE: ALL DIMENSIONS ARE IN m.

CLEARANCES (m)		63KV	20KV
1	Minimum height of the base of all post type or bushing insulators from ground	2.5	2.5
2	Min. clearance between live metal and ground potential	0.8	0.4
3	Min. clearance between Energized portions of different phases	0.95	0.5
4	Minimum Clearance Between Energized Parts Above Grades	3.3	3
5	Minimum Distance Between Phases of Main Suspension Buses	2.2	1.25
6	Minimum Vertical Clearances of Overhead lines Above Main Roadway	7	7


ABBREVIATION	DESCRIPTION
CVT	CAPACITIVE VOLTAGE TRANSFORMER
LMU	LINE MACHING UNIT
LT	LINE TRAP
CT	CURRENT TRANSFORMER
CB	CIRCUIT BREAKER
DS	DISCONNECTING SWITCH
DSE	DISCONNECTING SWITCH WITH EARTHING SWITCH
P.T.R	POWER TRANSFORMER
AUX.T	AUXILIARY TRANSFORMER
E.T.R	EARTHING TRANSFORMER
NCT	NEUTRAL CURRENT TRANSFORMER
LA	LIGHTNING ARRESTER
PI	POST INSULATOR
GA	GANTRY
S.T	STATIC TOWER
FW	FIRE WALL
F.F.K	FIRE FIGHTING KIOSK





POINT	X	Y
A	284430.18	4084934.37
B	284436.10	4085050.89
C	284480.18	4085004.37
D	284480.18	4084934.37

T01-T02 POWER TRANSFORMER 63/20KV 50MVA YNd11	Aux.T1-Aux.T2 AUXILLIARY TRANSFORMER 20/0.4KV 250KVA Dyn5	ER.T1-ER.T2 EARTHING TRANSFORMER 20KV 1554A Zn
---	---	--


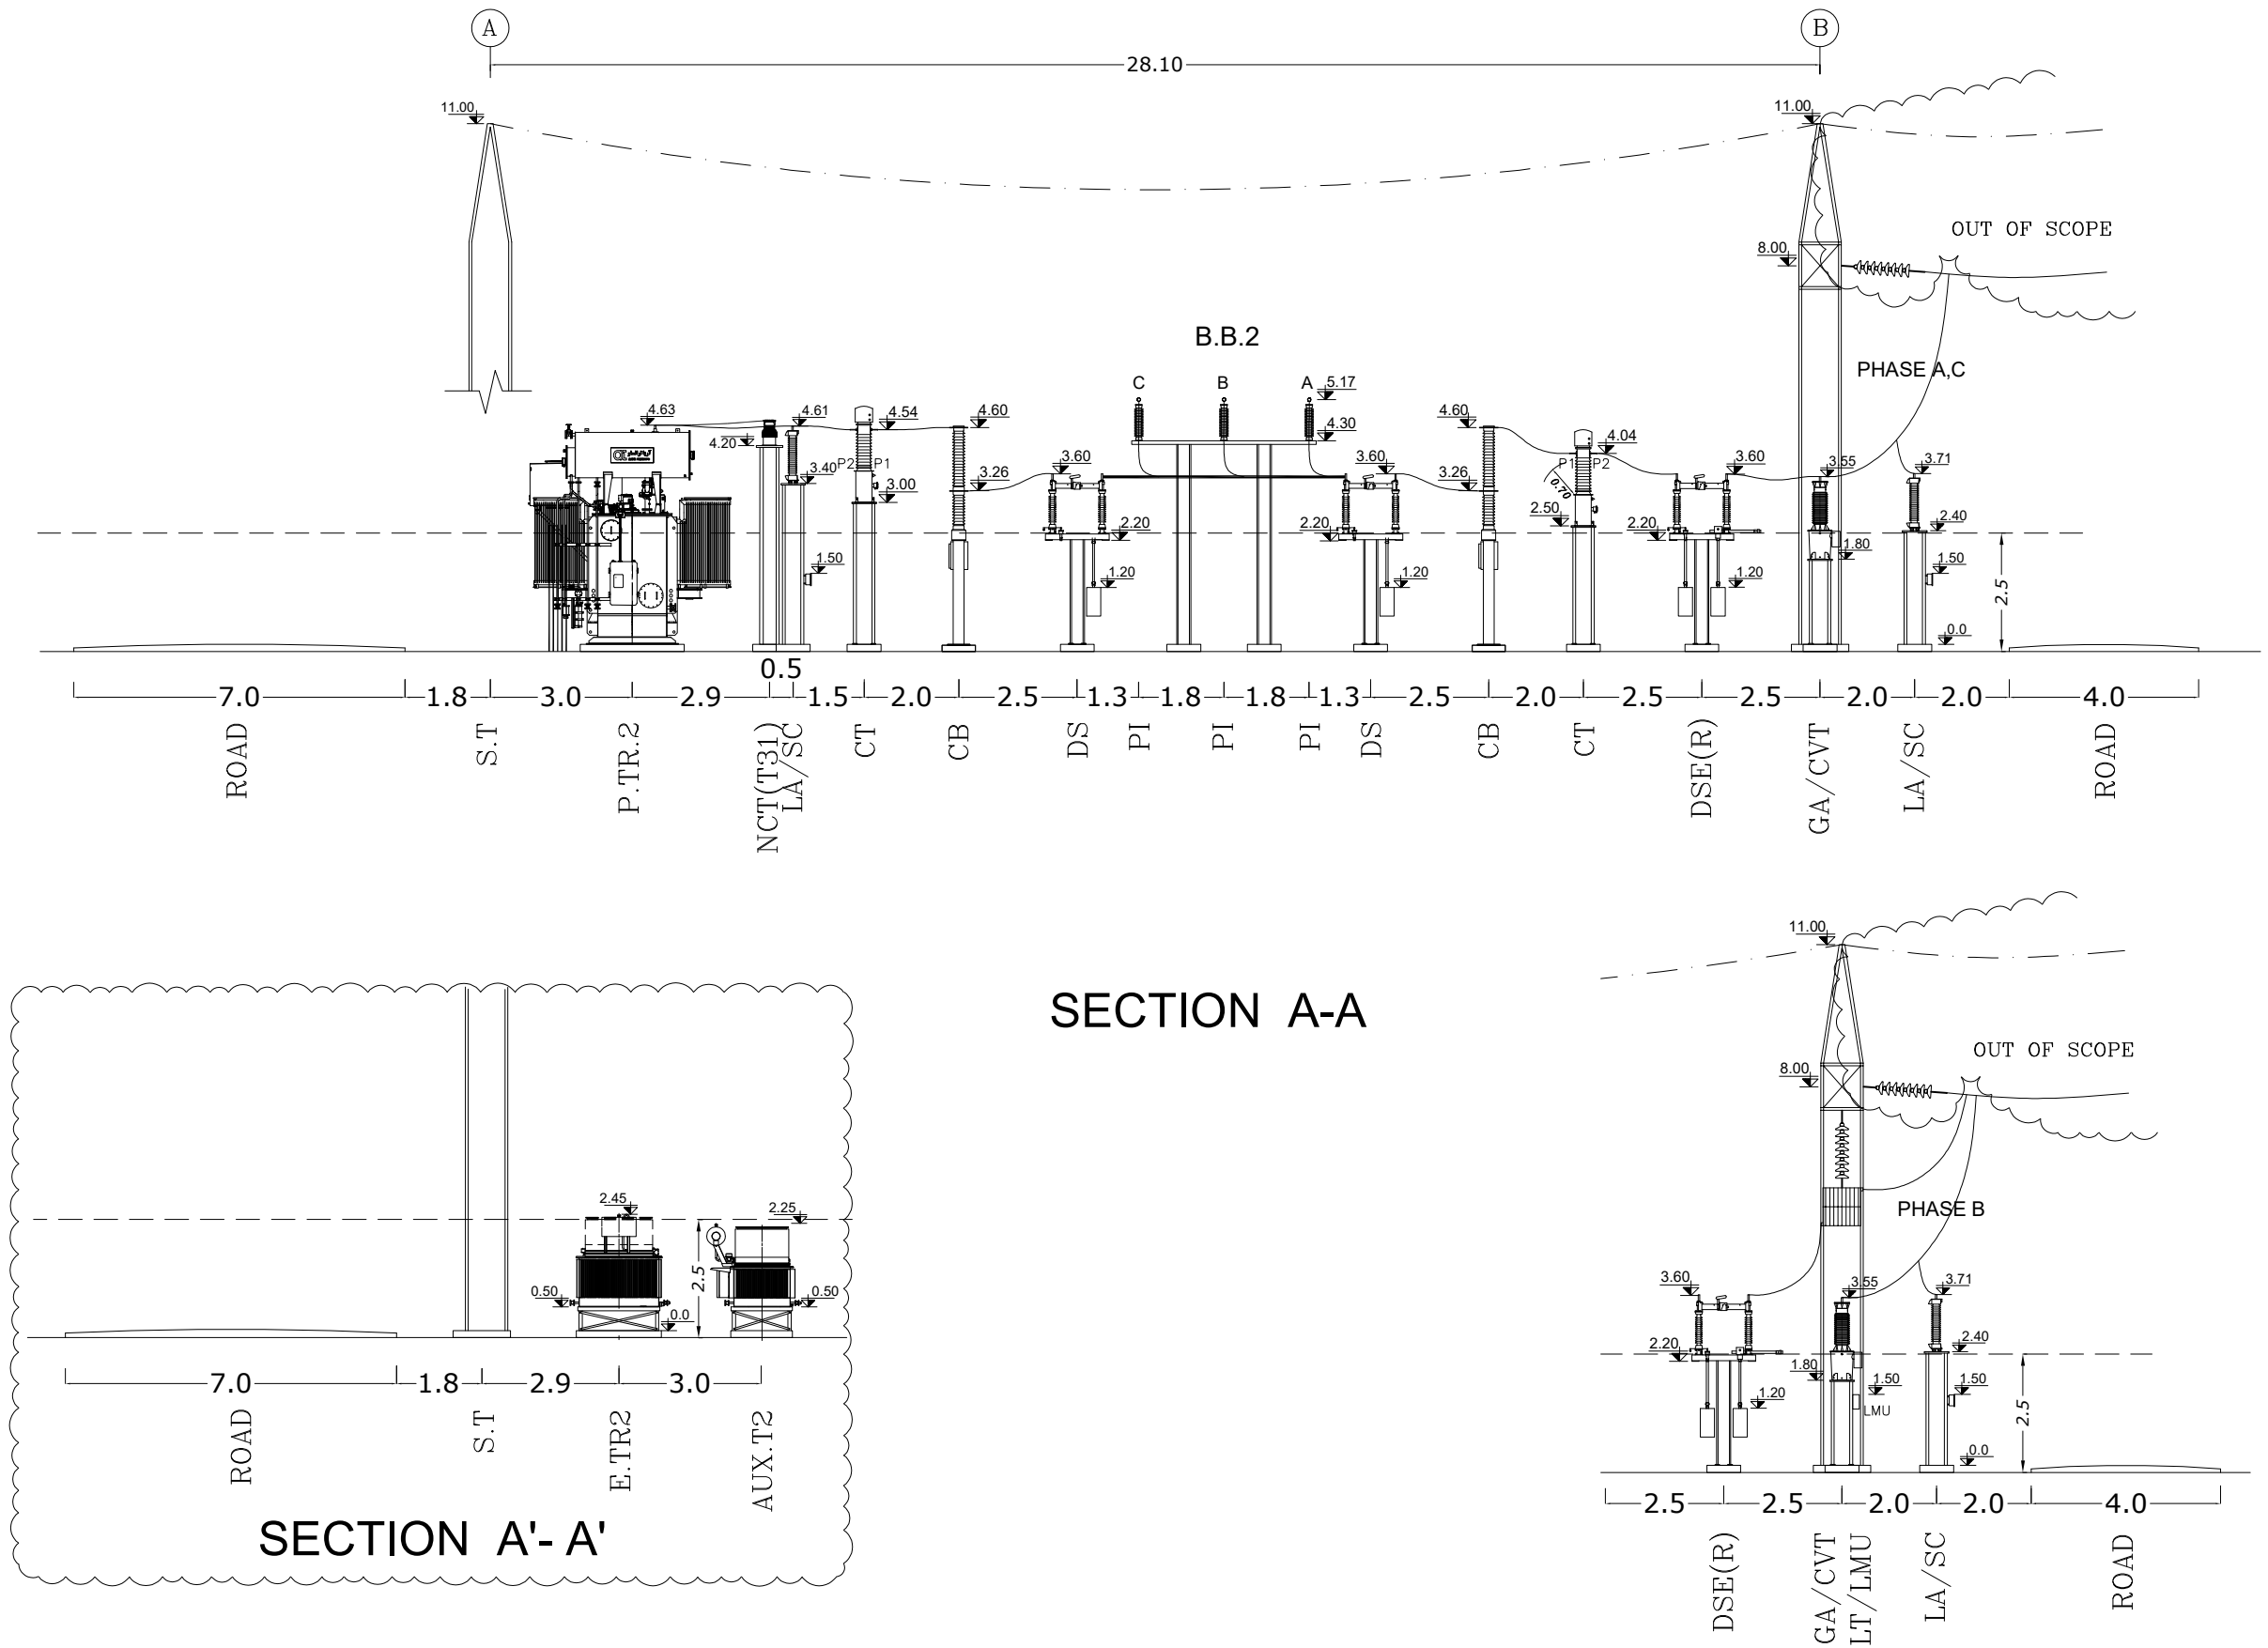
 MAZANDARAN REGIONAL ELECTRIC COMPANY (M.R.E.C.) MAPNA'S DWG. No. : MD1-BQ-06-SS-E-01-NYO-706	SUB-CONTRACTOR'S LOGO SUB CONTRACTOR DWG. NO.: NIYAM'S LOGO	E						DWG./Doc. No. MD1-BQ-06-SS-E-01-NYO-706	SCALE : 1/350	 MOHAM SHARGH CO. PROJECT : SORKHANKALATEH 63/20KV AIS S/S	
		D	ISSUE FOR APPROVE	GHAFOURIAN	GHAFOURIAN	M.NOORI	DANESHPOU				
		C	ACC TO LET NO.1403/179502/52320	GHAFOURIAN	GHAFOURIAN	M.NOORI	DANESHPOU				
		B	ACC TO LET NO.1403/179502/52320	EMARLOO	M.NOORI	M.NOORI	DANESHPOU				
		A	ACC TO LET NO.1403/179502/43747	EMARLOO	M.NOORI	M.NOORI	DANESHPOU	DRAWING TITLE: GENERAL LAYOUT	REV. NO. : D SHEET: 2 OF: 8		
		O	FIRST ISSUE	EMARLOO	M.NOORI	M.NOORI	DANESHPOU				
		REV.	DESCRIPTION	DWN	DESN	CHKD	APPR				

THIS DOCUMENT IS A PROPERTY OF MAPNA AND IT MUST NOT BE COPIED,
NOR TRANSFERRED TO A THIRD PARTY WITHOUT PRIOR AUTHORIZATION






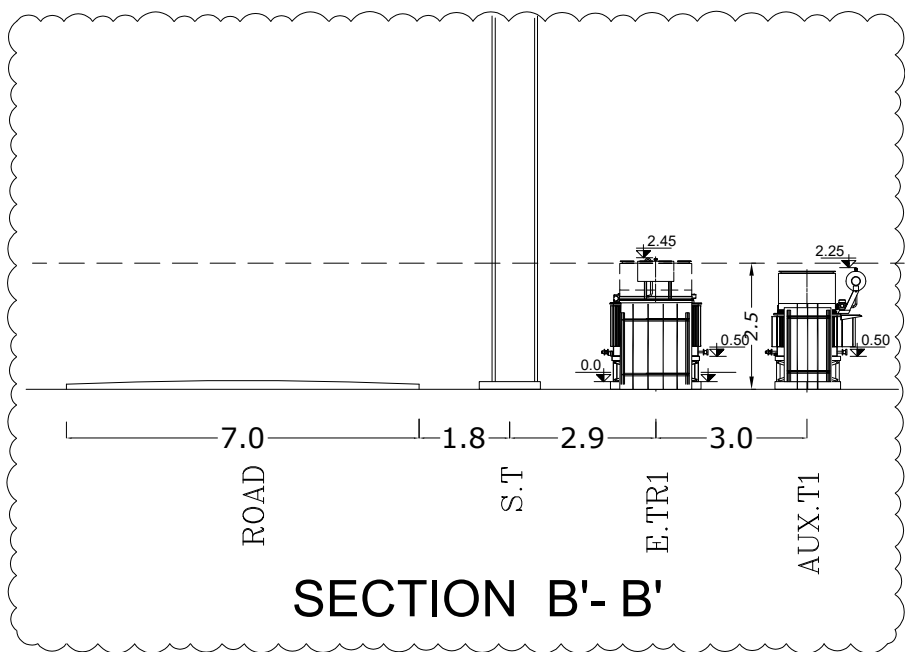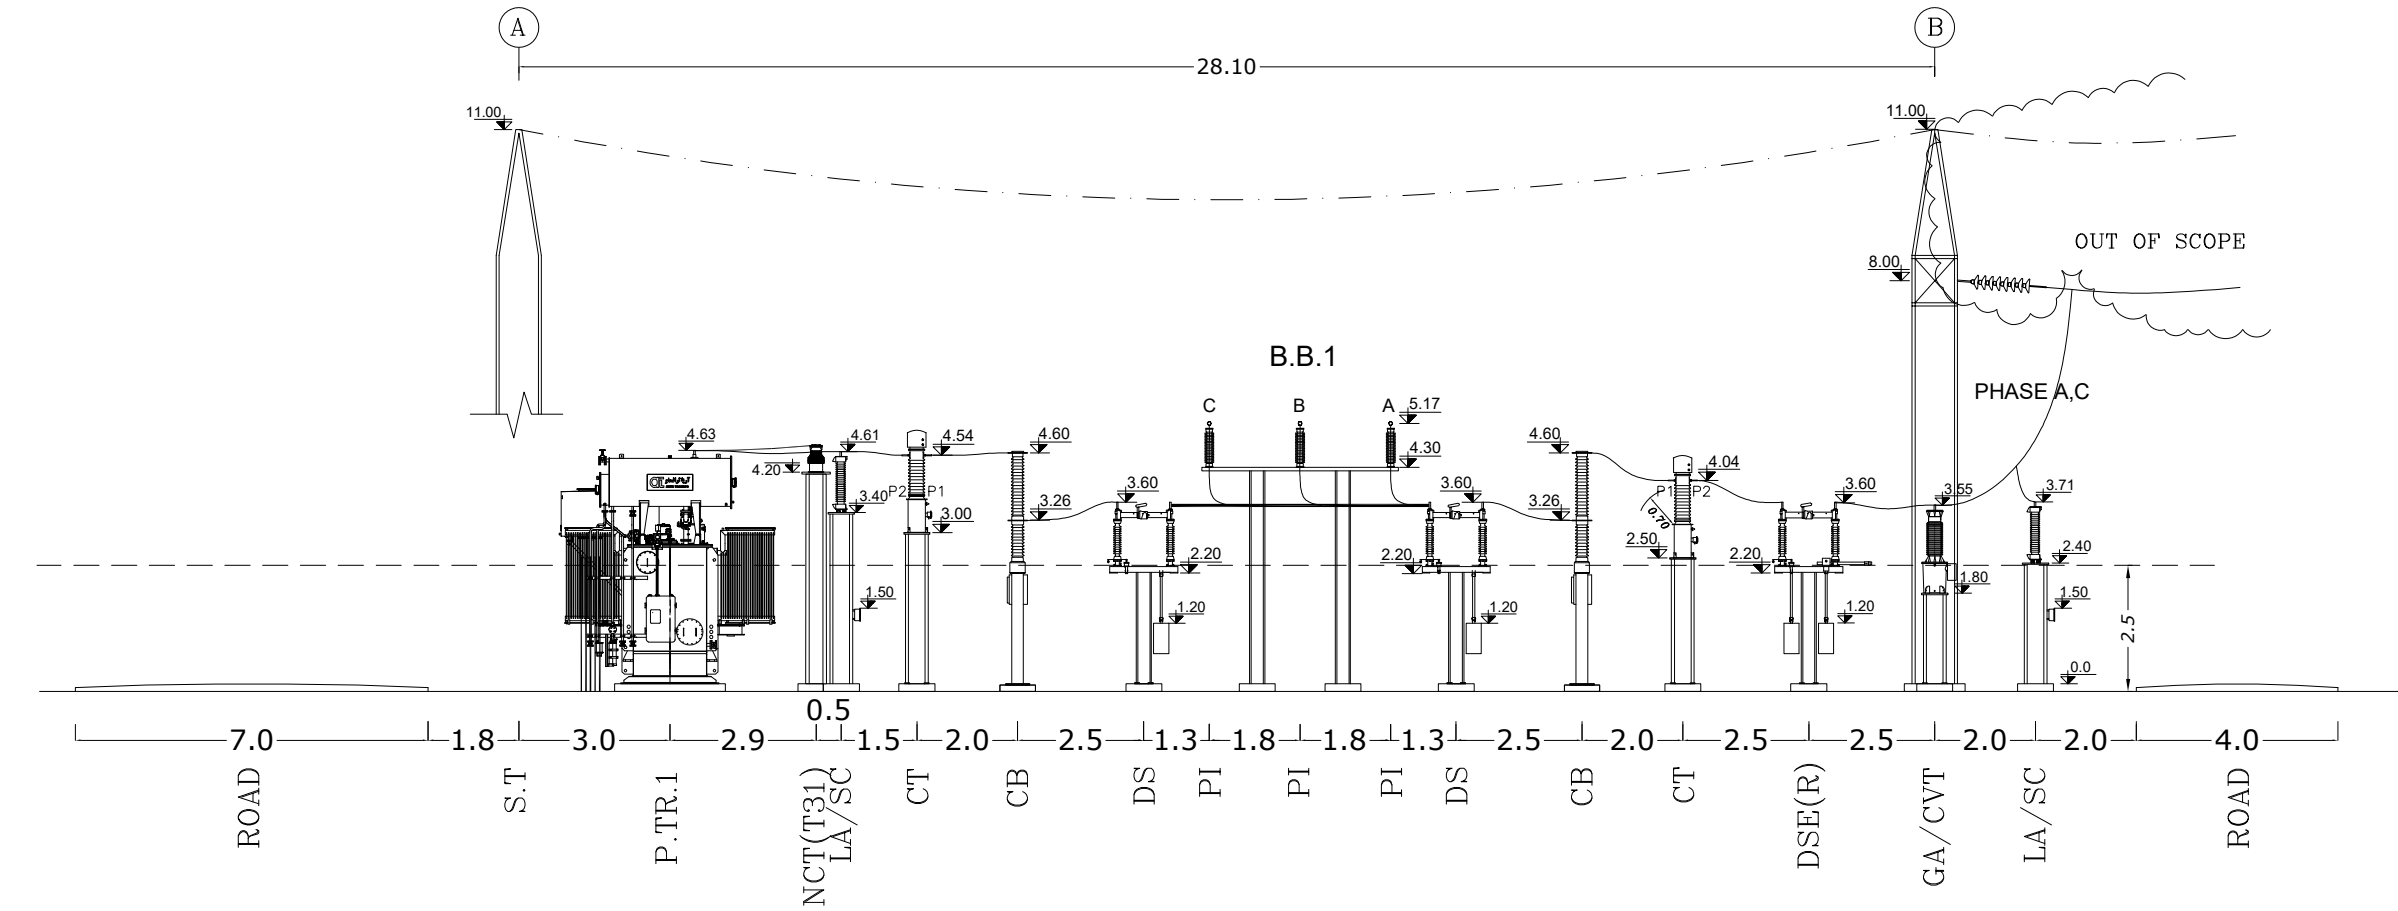

<div><p>MAZANDARAN REGIONAL ELECTRIC COMPANY</p></div> <div>MAPNA'S DWG. No. : MD1-BQ-06-SS-E-01-NY0-706</div>	<div>SUB-CONTRACTOR'S LOGO</div> <div>SUB CONTRACTOR DWG. NO.:</div> <div>NIYAM'S LOGO</div>	E							DWG./Doc. No. MD1-BQ-06-SS-E-01-NY0-706	SCALE : 1/150	<div><p>Mapna Power Plants Construction & Development Co(MD-1)</p></div> <div>PROJECT : SORKHANKALATEH 63/20KV AIS S/S</div>	<div><p>MOHAM SHARGH CO.</p></div>	<div><p>GHODS NIROO CONSULTING ENGINEERS</p></div>
		D	ISSUE FOR APPROVE	GHAFOURIAN	GHAFOURIAN	M.NOORI	DANESHPOU	04.02.21					
		C	ACC TO LET NO.1403/179502/52320	GHAFOURIAN	GHAFOURIAN	M.NOORI	DANESHPOU	04.01.23					
		B	ACC TO LET NO.1403/179502/52320	EMARLOO	M.NOORI	M.NOORI	DANESHPOU	03.12.06					
		A	ACC TO LET NO.1403/179502/43747	EMARLOO	M.NOORI	M.NOORI	DANESHPOU	03.10.03	DRAWING TITLE: SECTION A-A	REV. NO. : D SHEET: 3 OF: 8			
		O	FIRST ISSUE	EMARLOO	M.NOORI	M.NOORI	DANESHPOU	03.07.14					
		REV.	DESCRIPTION	DWN	DESN	CHKD	APPR	DATE					

THIS DOCUMENT IS A PROPERTY OF MAPNA AND IT MUST NOT BE COPIED,
NOR TRANSFERRED TO A THIRD PARTY WITHOUT PRIOR AUTHORIZATION

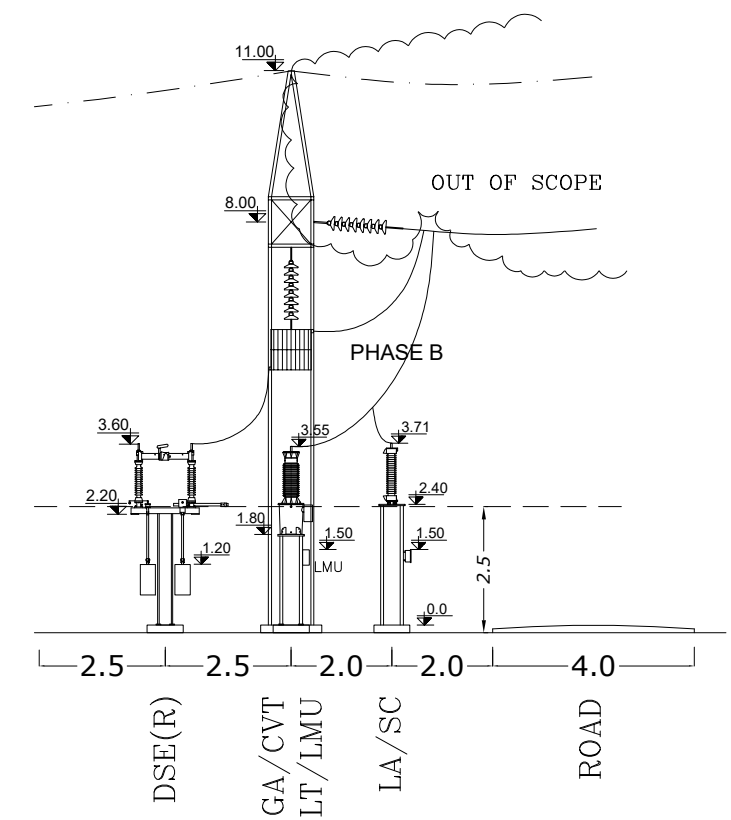


SECTION B-B





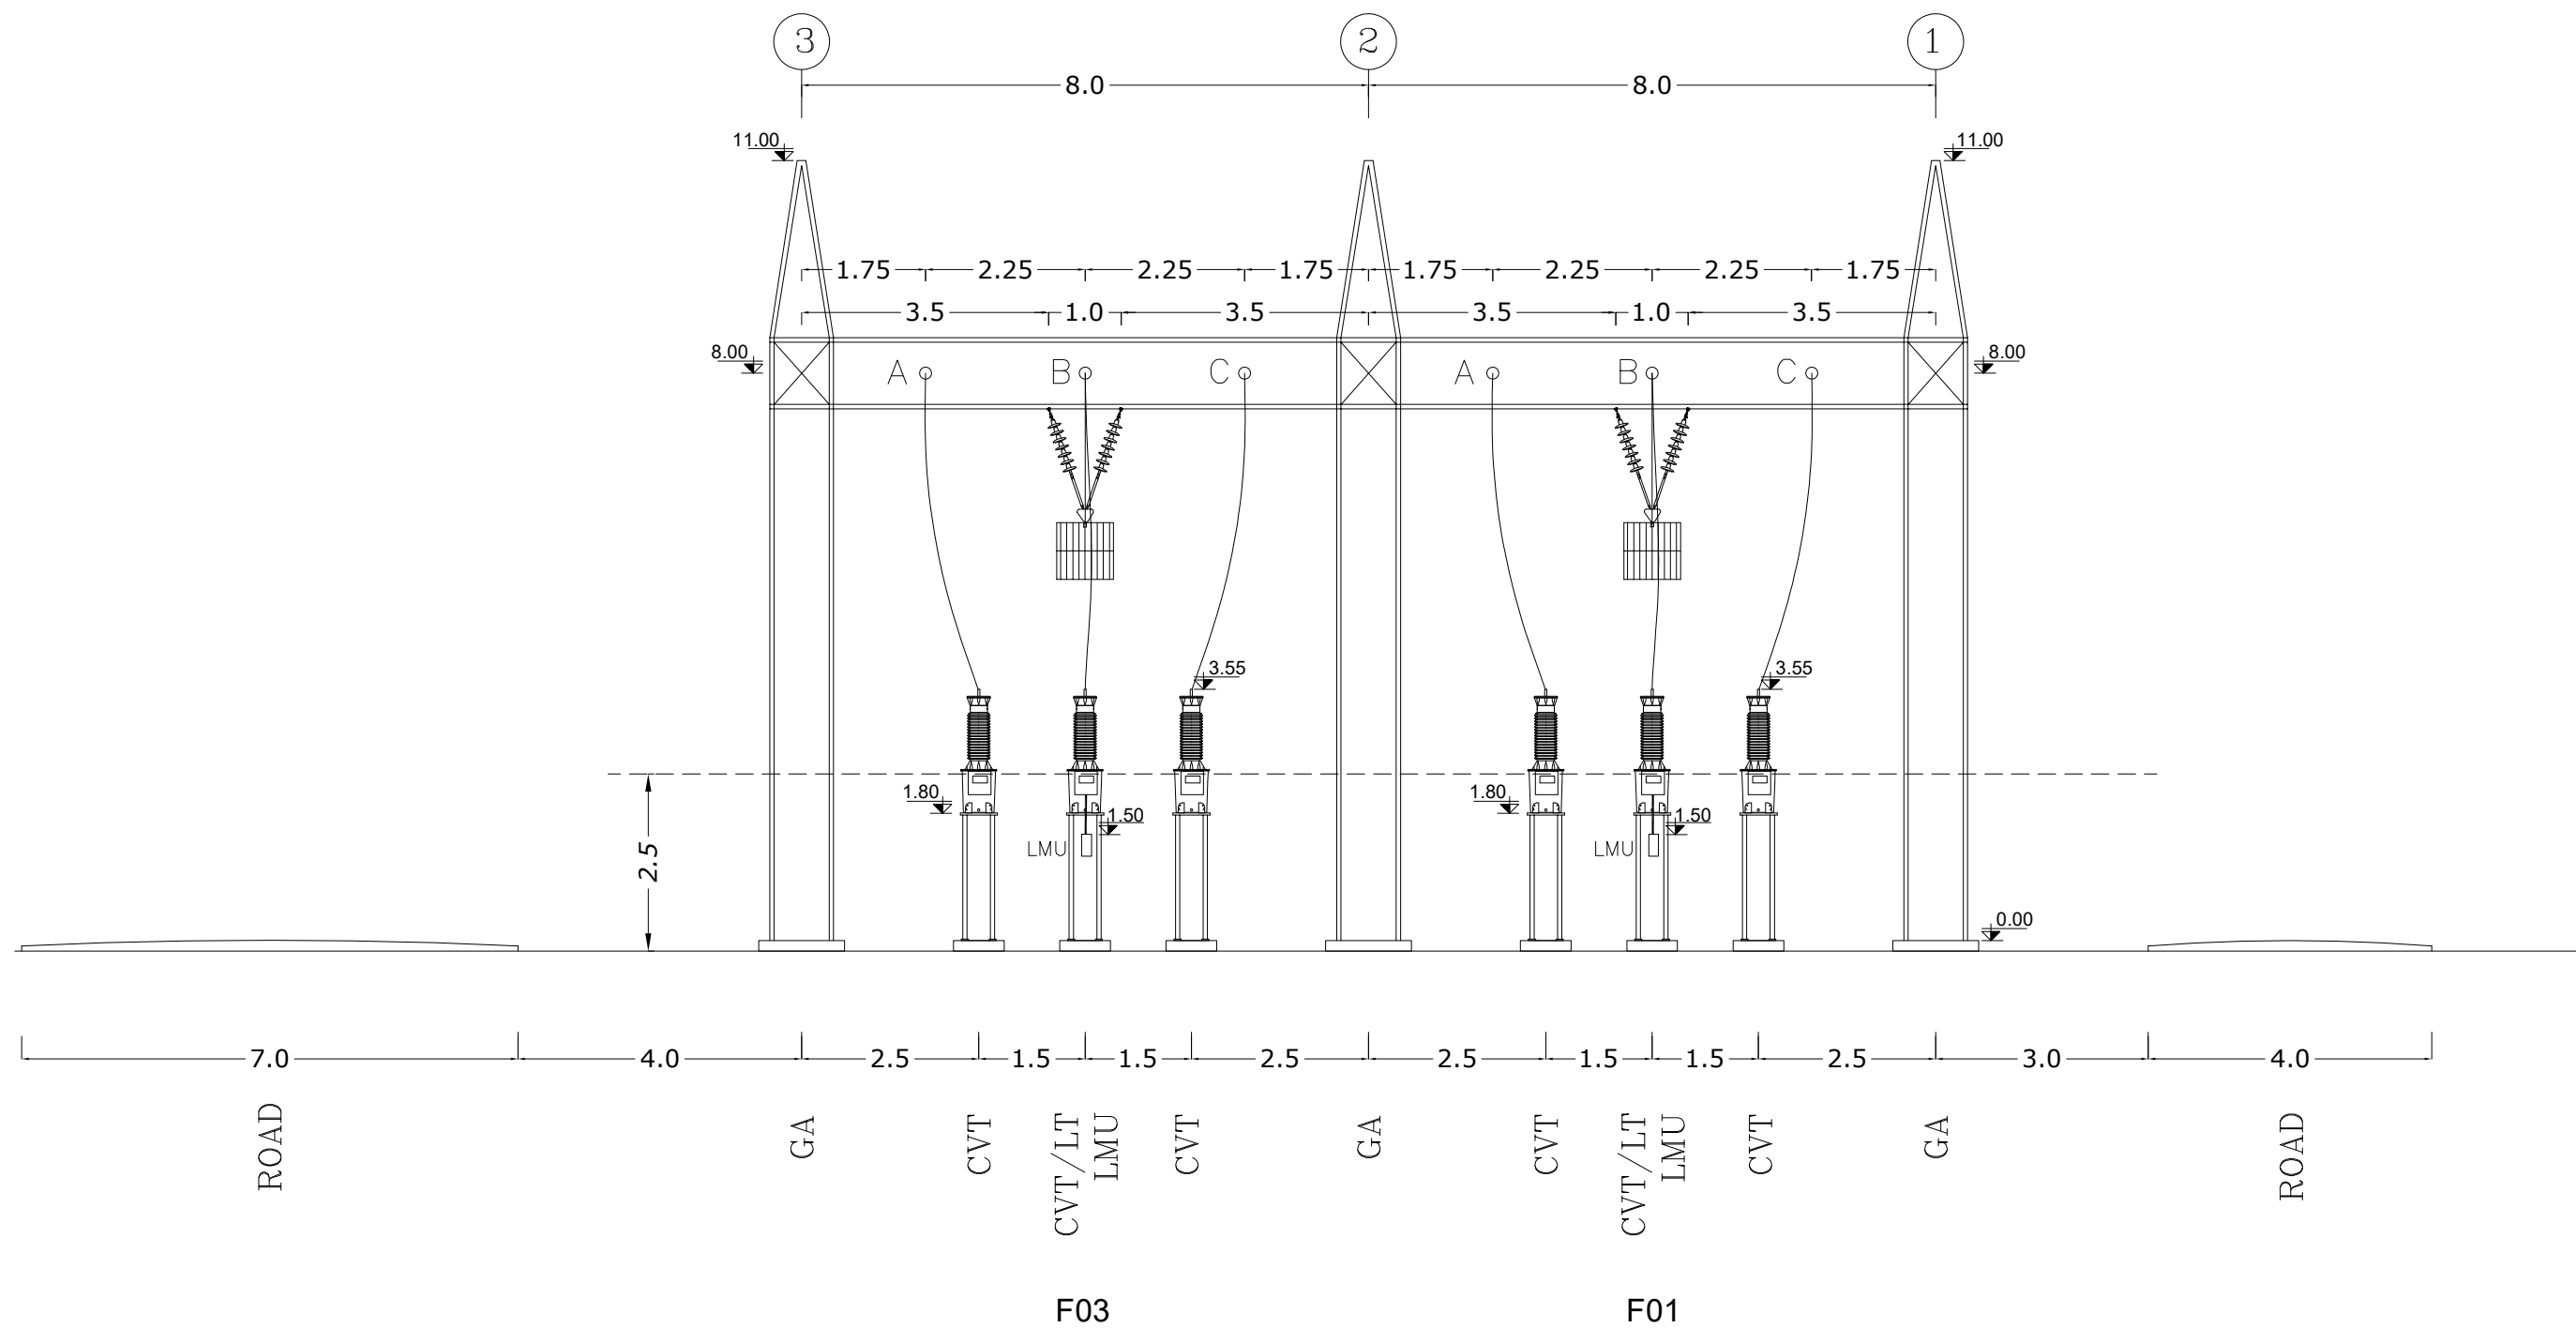

<div></div> <div>MAZANDARAN REGIONAL ELECTRIC COMPANY (M.R.E.C)</div>	SUB-CONTRACTOR'S LOGO	E						DWG./Doc. No. MD1-BQ-06-SS-E-01-NYO-706	SCALE : 1/150	<div></div> <div>Mapna Power Plants Construction & Development Co(MD-1)</div>	<div></div> <div>MOHAM SHARGH CO.</div>	<div></div> <div>GHODS NIROO CONSULTING ENGINEERS</div>			
		D	ISSUE FOR APPROVE	GHAFOURIAN	GHAFOURIAN	M.NOORI	DANESHPOU						04.02.21		
		C	ACC TO LET NO.1403/179502/52320	GHAFOURIAN	GHAFOURIAN	M.NOORI	DANESHPOU						04.01.23		
	SUB CONTRACTOR DWG. NO.:	B	ACC TO LET NO.1403/179502/52320	EMARLOO	M.NOORI	M.NOORI	DANESHPOU						03.12.06	DRAWING TITLE: SECTION B-B	REV. NO. : D SHEET: 4 OF: 8
		A	ACC TO LET NO.1403/179502/43747	EMARLOO	M.NOORI	M.NOORI	DANESHPOU						03.10.03		
MAPNA'S DWG. No. : MD1-BQ-06-SS-E-01-NYO-706	NIYAM'S LOGO	O	FIRST ISSUE	EMARLOO	M.NOORI	M.NOORI	DANESHPOU	03.07.14	DESIGN STAGE :	FILE No.	FORMAT : A3	PROJECT : SORKHANKALATEH 63/20KV AIS S/S			
		REV.	DESCRIPTION	DWN	DESN	CHKD	APPR	DATE							

THIS DOCUMENT IS A PROPERTY OF MAPNA AND IT MUST NOT BE COPIED,
NOR TRANSFERRED TO A THIRD PARTY WITHOUT PRIOR AUTHORIZATION




SECTION C-C

<div> MAZANDARAN REGIONAL ELECTRIC COMPANY (M.R.E.C)</div>	SUB-CONTRACTOR'S LOGO	E							DWG./Doc. No. MD1-BQ-06-SS-E-01-NYO-706	SCALE :1/100	<div> Mapna Power Plants Construction & Development Co(MD-1)</div>	<div>MOHAM SHARGH CO.</div> <div></div>	<div>GHODS NIROO CONSULTING ENGINEERS</div>		
		D	ISSUE FOR APPROVE	GHAFOURIAN	GHAFOURIAN	M.NOORI	DANESHPOU	04.02.21							
		C	ACC TO LET NO.1403/179502/52320	GHAFOURIAN	GHAFOURIAN	M.NOORI	DANESHPOU	04.01.23							
	SUB CONTRACTOR DWG. NO.:	B	ACC TO LET NO.1403/179502/52320	EMARLOO	M.NOORI	M.NOORI	DANESHPOU	03.12.06						DRAWING TITLE: SECTION C-C	REV. NO. : D
		A	ACC TO LET NO.1403/179502/43747	EMARLOO	M.NOORI	M.NOORI	DANESHPOU	03.10.03							SHEET: 5 OF: 8
MAPNA'S DWG. No. : MD1-BQ-06-SS-E-01-NYO-706	NIYAM'S LOGO	O	FIRST ISSUE	EMARLOO	M.NOORI	M.NOORI	DANESHPOU	03.07.14	DESIGN STAGE :	FILE No.	FORMAT : A3	PROJECT : SORKHANKALATEH 63/20KV AIS S/S			
		REV.	DESCRIPTION	DWN	DESN	CHKD	APPR	DATE							

SECTION D-D

SECTION E-E

REV.	DESCRIPTION	DWN	DESN	CHKD	APPR	DATE
O	FIRST ISSUE	EMARLOO	M.NOORI	M.NOORI	DANESHPOU	03.07.14
A	ACC TO LET NO.1403/179502/43747	EMARLOO	M.NOORI	M.NOORI	DANESHPOU	03.10.03
B	ACC TO LET NO.1403/179502/52320	EMARLOO	M.NOORI	M.NOORI	DANESHPOU	03.12.06
C	ACC TO LET NO.1403/179502/52320	GHAFOURIAN	GHAFOURIAN	M.NOORI	DANESHPOU	04.01.23
D	ISSUE FOR APPROVE	GHAFOURIAN	GHAFOURIAN	M.NOORI	DANESHPOU	04.02.21
E						



MAZANDARAN
REGIONAL ELECTRIC
COMPANY (M.R.E.C)

MAPNA'S DWG. No. :
MD1-BQ-06-SS-E-01-NY0-706

SUB-CONTRACTOR'S LOGO

SUB CONTRACTOR DWG. NO.:

NIYAM'S LOGO

DWG./Doc. No. MD1-BQ-06-SS-E-01-NY0-706

DRAWING TITLE:
SECTION D-D&E-E

DESIGN STAGE :


FILE No.

SCALE : 1/100

REV. NO. : D

SHEET: 6 OF: 8


FORMAT : A3




Mapna Power Plants Construction &
Development Co(MD-1)





PROJECT :
SORKHANKALATEH 63/20KV AIS S/S

MOHAM SHARGH CO.










GHODS NIROO
CONSULTING ENGINEERS
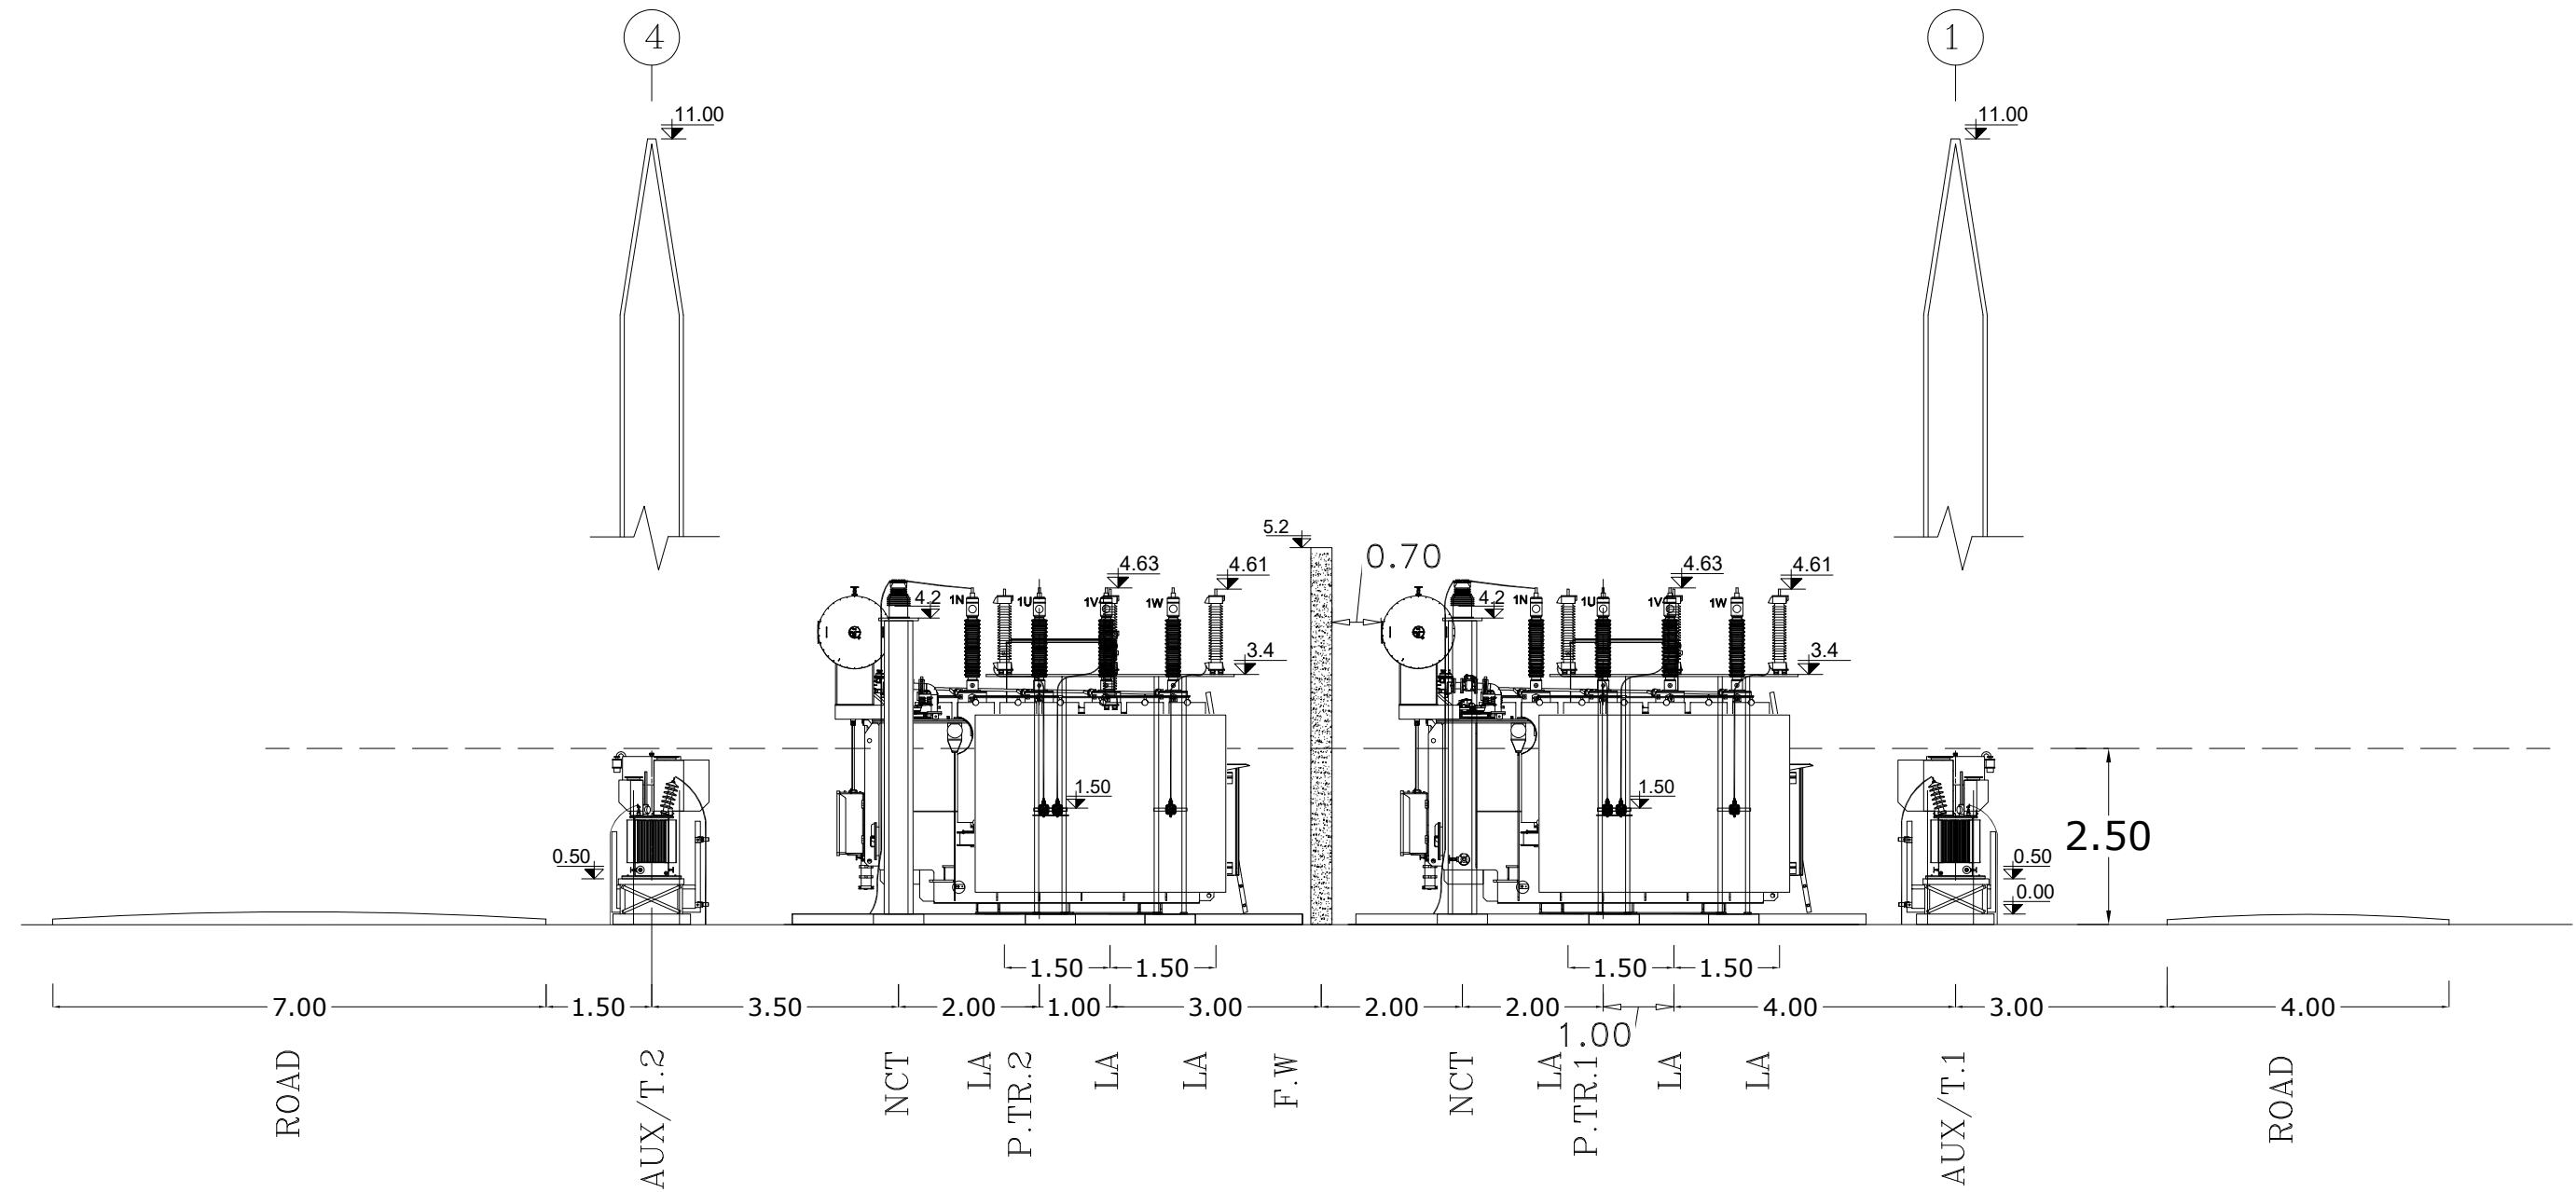
<div></div> <div>MAZANDARAN REGIONAL ELECTRIC COMPANY (M.R.E.C)</div>	SUB-CONTRACTOR'S LOGO	E						DWG./Doc. No. MD1-BQ-06-SS-E-01-NY0-706	SCALE : 1/100	<div></div> <div>Mapna Power Plants Construction & Development Co(MD-1)</div>	<div></div> <div>MOHAM SHARGH CO.</div>	<div></div> <div>GHODS NIROO CONSULTING ENGINEERS</div>	
		D	ISSUE FOR APPROVE	GHAFOURIAN	GHAFOURIAN	M.NOORI	DANESHPOU						04.02.21
		C	ACC TO LET NO.1403/179502/52320	GHAFOURIAN	GHAFOURIAN	M.NOORI	DANESHPOU						04.01.23
	SUB CONTRACTOR DWG. NO.:	B	ACC TO LET NO.1403/179502/52320	EMARLOO	M.NOORI	M.NOORI	DANESHPOU	03.12.06	DRAWING TITLE: SECTION D-D&E-E	REV. NO. : D	SHEET: 6 OF: 8		
		A	ACC TO LET NO.1403/179502/43747	EMARLOO	M.NOORI	M.NOORI	DANESHPOU	03.10.03					
		O	FIRST ISSUE	EMARLOO	M.NOORI	M.NOORI	DANESHPOU	03.07.14					
	MAPNA'S DWG. No. : MD1-BQ-06-SS-E-01-NY0-706	NIYAM'S LOGO	REV.	DESCRIPTION	DWN	DESN	CHKD	APPR	DATE	DESIGN STAGE :	FILE No.	FORMAT : A3	PROJECT : SORKHANKALATEH 63/20KV AIS S/S


THIS DOCUMENT IS A PROPERTY OF MAPNA AND IT MUST NOT BE COPIED,
NOR TRANSFERRED TO A THIRD PARTY WITHOUT PRIOR AUTHORIZATION



 



SECTION F-F

<div></div> <div>MAZANDARAN REGIONAL ELECTRIC COMPANY (M.R.E.C.)</div>	SUB-CONTRACTOR'S LOGO	E							DWG./Doc. No. MD1-BQ-06-SS-E-01-NY0-706	SCALE : 1/100	<div></div> <div>Mapna Power Plants Construction & Development Co(MD-1)</div>	<div></div> <div>MOHAM SHARGH CO.</div>	<div></div> <div>GHODS NIROO CONSULTING ENGINEERS</div>	
		D	ISSUE FOR APPROVE	GHAFOURIAN	GHAFOURIAN	M.NOORI	DANESHPOU	04.02.21						
		C	ACC TO LET NO.1403/179502/52320	GHAFOURIAN	GHAFOURIAN	M.NOORI	DANESHPOU	04.01.23						
	SUB CONTRACTOR DWG. NO.:	B	ACC TO LET NO.1403/179502/52320	EMARLOO	M.NOORI	M.NOORI	DANESHPOU	03.12.06	DRAWING TITLE: SECTION F-F	REV. NO. : D				SHEET: 7 OF: 8
		A	ACC TO LET NO.1403/179502/43747	EMARLOO	M.NOORI	M.NOORI	DANESHPOU	03.10.03						
MAPNA'S DWG. No. : MD1-BQ-06-SS-E-01-NY0-706	NIYAM'S LOGO	O	FIRST ISSUE	EMARLOO	M.NOORI	M.NOORI	DANESHPOU	03.07.14	DESIGN STAGE :	FILE No.	FORMAT : A3	PROJECT : SORKHANKALATEH 63/20KV AIS S/S		
		REV.	DESCRIPTION	DWN	DESN	CHKD	APPR	DATE						

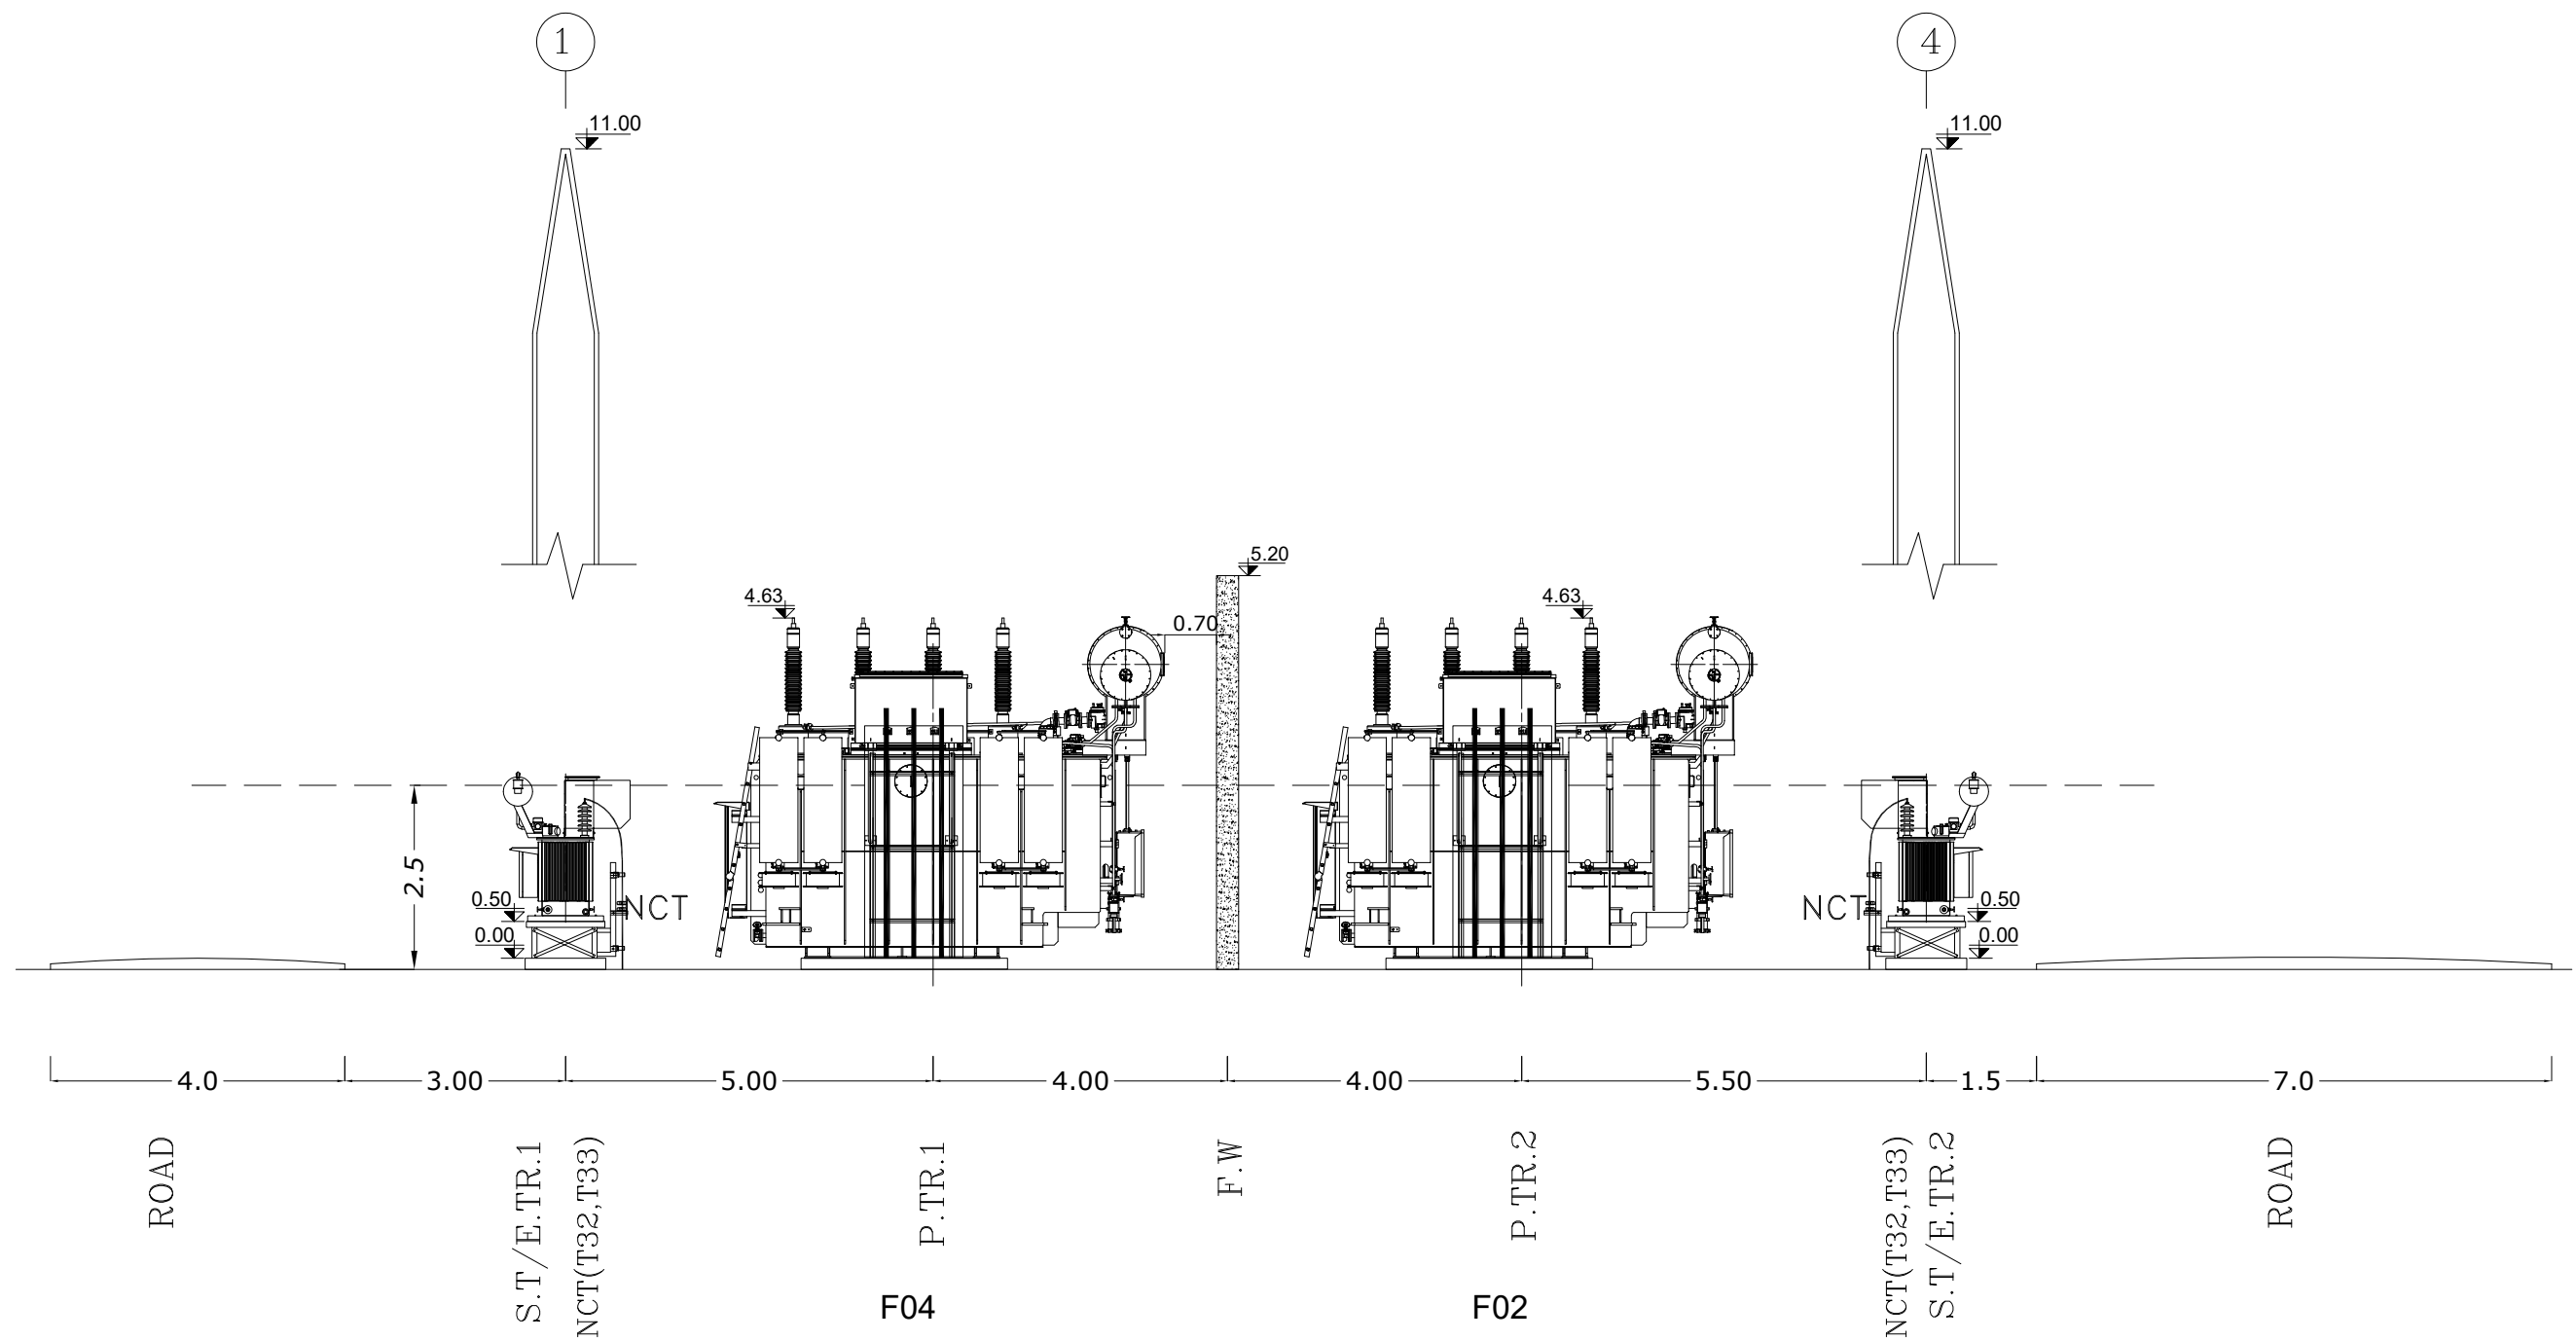THIS DOCUMENT IS A PROPERTY OF MAPNA AND IT MUST NOT BE COPIED,
NOR TRANSFERRED TO A THIRD PARTY WITHOUT PRIOR AUTHORIZATION



SECTION G-G

<div></div> <div>MAZANDARAN REGIONAL ELECTRIC COMPANY (M.R.E.C)</div>	SUB-CONTRACTOR'S LOGO	E						DWG./Doc. No. MD1-BQ-06-SS-E-01-NYO-706	SCALE :1/100	<div></div> <div>Mapna Power Plants Construction & Development Co(MD-1)</div>	<div></div> <div>MOHAM SHARGH CO.</div>	<div></div> <div>GHODS NIROO CONSULTING ENGINEERS</div>				
		D	ISSUE FOR APPROVE	GHAFOURIAN	GHAFOURIAN	M.NOORI	DANESHPOU						04.02.21			
		C	ACC TO LET NO.1403/179502/52320	GHAFOURIAN	GHAFOURIAN	M.NOORI	DANESHPOU						04.01.23			
	SUB CONTRACTOR DWG. NO.:	B	ACC TO LET NO.1403/179502/52320	EMARLOO	M.NOORI	M.NOORI	DANESHPOU						03.12.06	DRAWING TITLE: <div>SECTION G-G</div>	REV. NO. : D	SHEET: 8 OF: 8
		A	ACC TO LET NO.1403/179502/43747	EMARLOO	M.NOORI	M.NOORI	DANESHPOU						03.10.03			
MAPNA'S DWG. No. : MD1-BQ-06-SS-E-01-NYO-706	NIYAM'S LOGO	O	FIRST ISSUE	EMARLOO	M.NOORI	M.NOORI	DANESHPOU	03.07.14	DESIGN STAGE :	FILE No.	FORMAT : A3	PROJECT : SORKHANKALATEH 63/20KV AIS S/S				
		REV.	DESCRIPTION	DWN	DESN	CHKD	APPR	DATE								